






NOTES:

1. GENERATOR SIZE AND CT RATIOS SHOWN ARE PRELIMINARY.
2. ITEMS NOT WITHIN CLOUDS ARE EXISTING.
3. CT'S SHALL BE WINDOW TYPE - BAR TYPE CT'S ARE NOT ALLOWED.

A	02/24/22	ISSUED FOR BID
Rev	Date	Description
 University of Missouri		
Project: Power Plant - Replace Turbine 6 with Turbine 10		
 Affiliated Engineers		MU Proj. No.: CP21157 AEI Proj. No.: 22020-00
Technical Specifications Steam Turbine Generator Electrical 1-Line		
Exhibit No.: EXHIBIT - B		Sheet No.: B-001

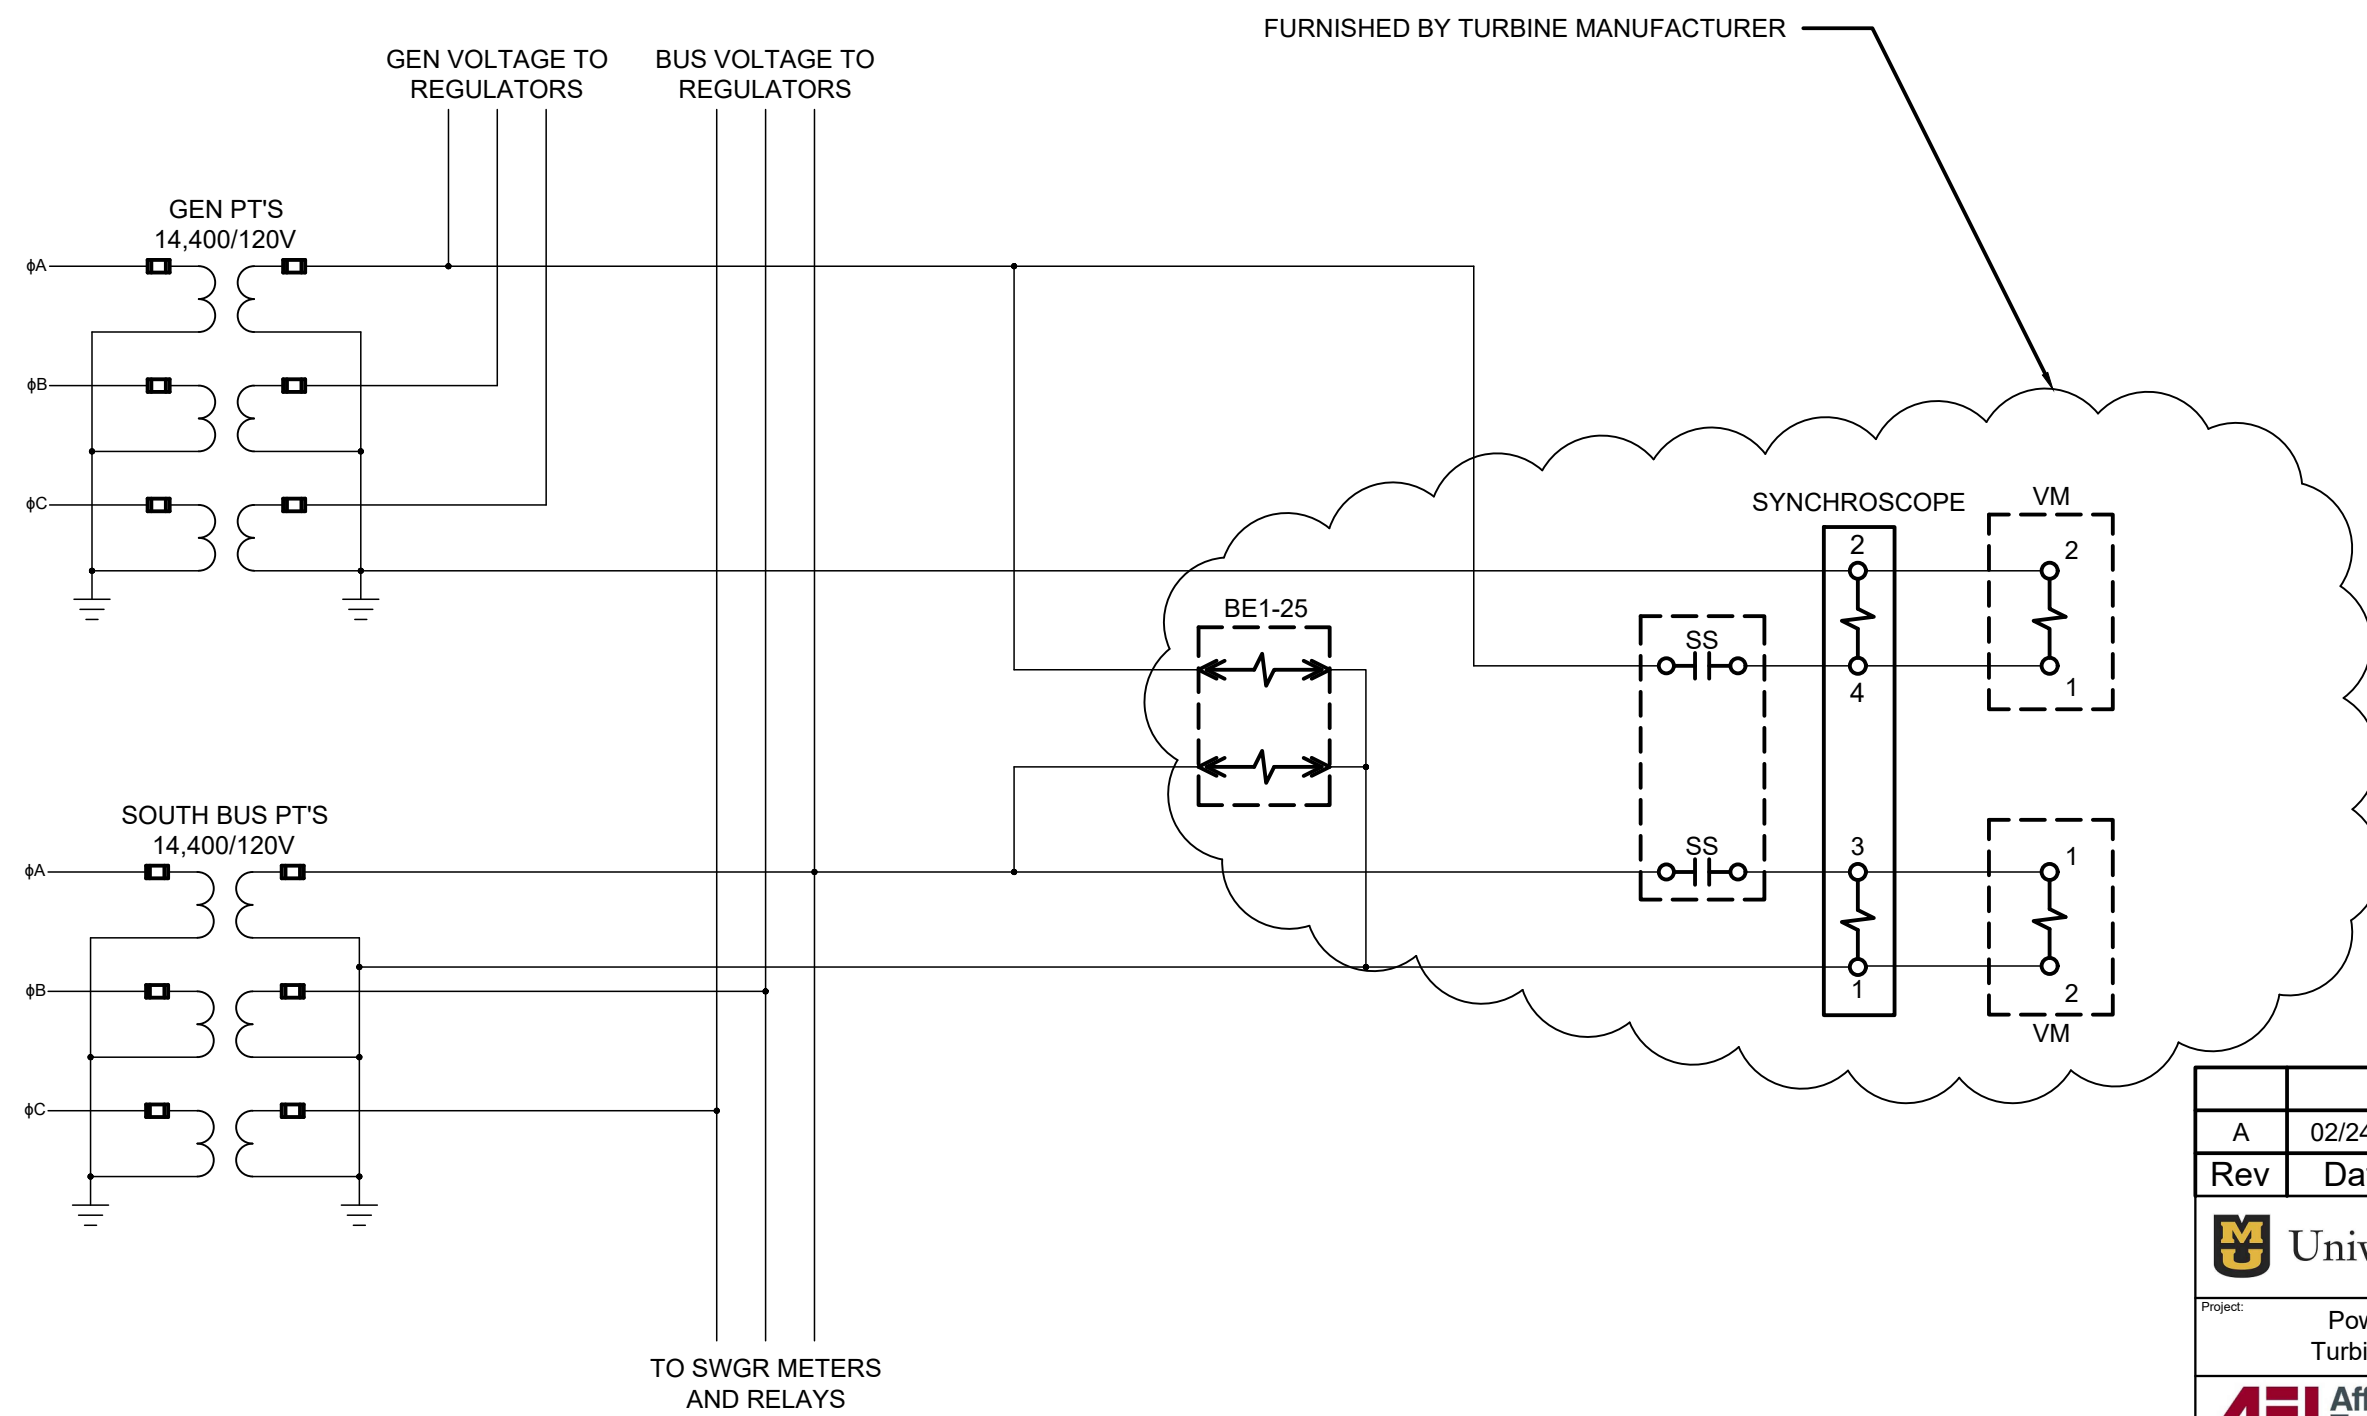

A	02/24/22	ISSUED FOR BID
Rev	Date	Description
<div><div> University of Missouri</div></div>		
Project: Power Plant - Replace Turbine 6 with Turbine 10		
<div><div> Affiliated Engineers</div></div>		MU Proj. No.: CP21157
		AEI Proj. No.: 22020-00
Technical Specifications Steam Turbine Generator		
Synchronizing Three-Line		
Exhibit No.: EXHIBIT - B		Sheet No.: B-002